




01 RESOURCE - ELEVATION A
SCALE 1/80

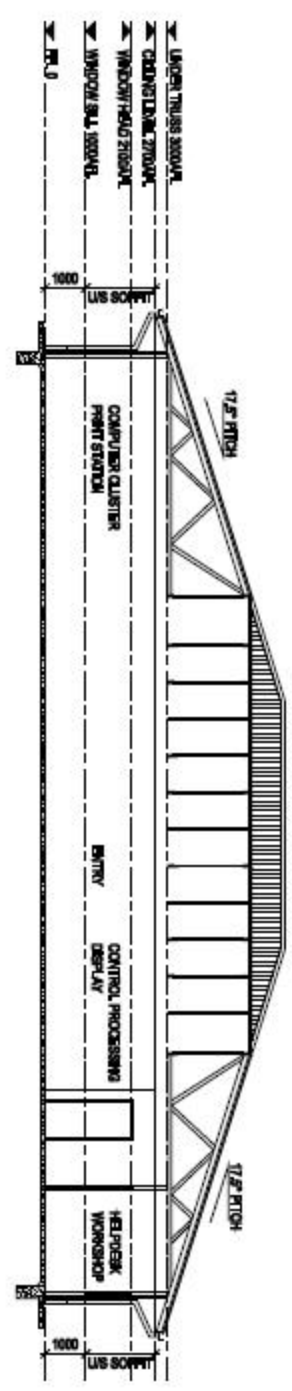

02 RESOURCE - SECTION AA
SCALE 1/80

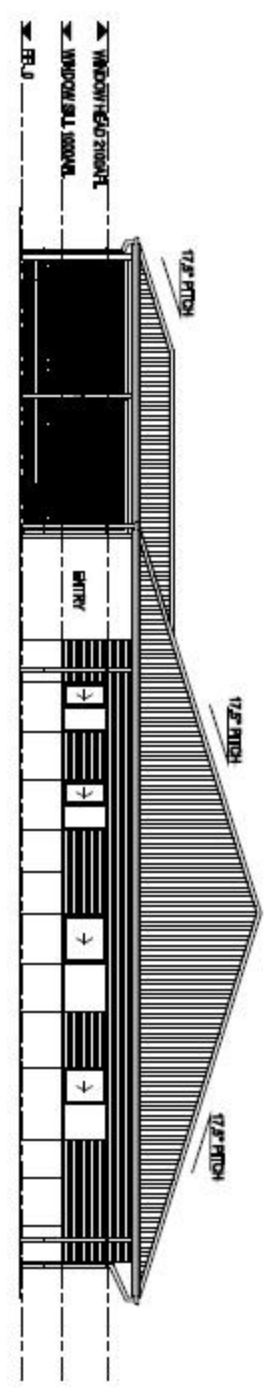

03 RESOURCE - ELEVATION B
SCALE 1/80

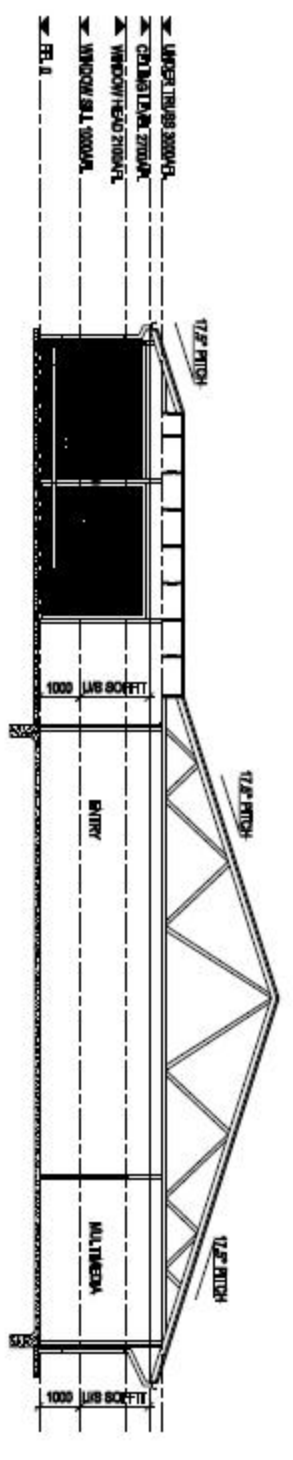

04 RESOURCE - SECTION BB
SCALE 1/80



BARCODE

DIMENSIONS
Use Imperial dimensions, OR METR SCALE
Units of dimension & scale is the metric notation of cent and millimetres.

AMENDMENTS

REV	DATE	SHEET	DESCRIPTION	AUTH	CHK
A			PRELIMINARY ISSUE		

DRAWINGS INDEXING SYSTEM
FOR PROJECT SERVICES, PLANS AND RECORDS (SEE ENCL 1)

<input type="checkbox"/> CIVIL PLAN	<input type="checkbox"/> ELECTRICAL DETAILS
<input type="checkbox"/> CONCRETE DETAILS	<input type="checkbox"/> MECHANICAL DETAILS
<input type="checkbox"/> FOUNDATION	<input type="checkbox"/> PLUMBING
<input type="checkbox"/> GENERAL NOTES	<input type="checkbox"/> ROOF PLAN
<input type="checkbox"/> ELEVATIONS	<input type="checkbox"/> SITE PLAN
<input type="checkbox"/> EXTERIOR	<input type="checkbox"/> SECTION
<input type="checkbox"/> EXTERIOR FINISHES	<input type="checkbox"/> SECTION PLAN
<input type="checkbox"/> EXTERIOR WALLS	<input type="checkbox"/> STRUCTURAL PLAN
<input type="checkbox"/> EXTERIOR ROOF	<input type="checkbox"/> STRUCTURAL PLAN
<input type="checkbox"/> EXTERIOR WALLS	<input type="checkbox"/> STRUCTURAL PLAN
<input type="checkbox"/> EXTERIOR WALLS	<input type="checkbox"/> STRUCTURAL PLAN



Queensland Government

Department of Education
Training and the Arts

© The State of Queensland 2015

DESIGNER	HS	DATE	March 2009
DRAWN	RP	DATE	March 2009
CHECKED	RP	DATE	March 2009
DATE	DATE	DATE	DATE

ALLOTTED FOR SCALE

DATE

BUILDING THE EDUCATION REVOLUTION

RESOURCE

SECTIONS & ELEVATIONS

RES 2

SCALE 1:100

SHEET NO. 17

TOTAL SHEETS 17

DATE 17/03/09

SCALE 1:100

SHEET NO. A1

TOTAL SHEETS 17

DATE 17/03/09

SCALE 1:100

SHEET NO. A

TOTAL SHEETS 17